
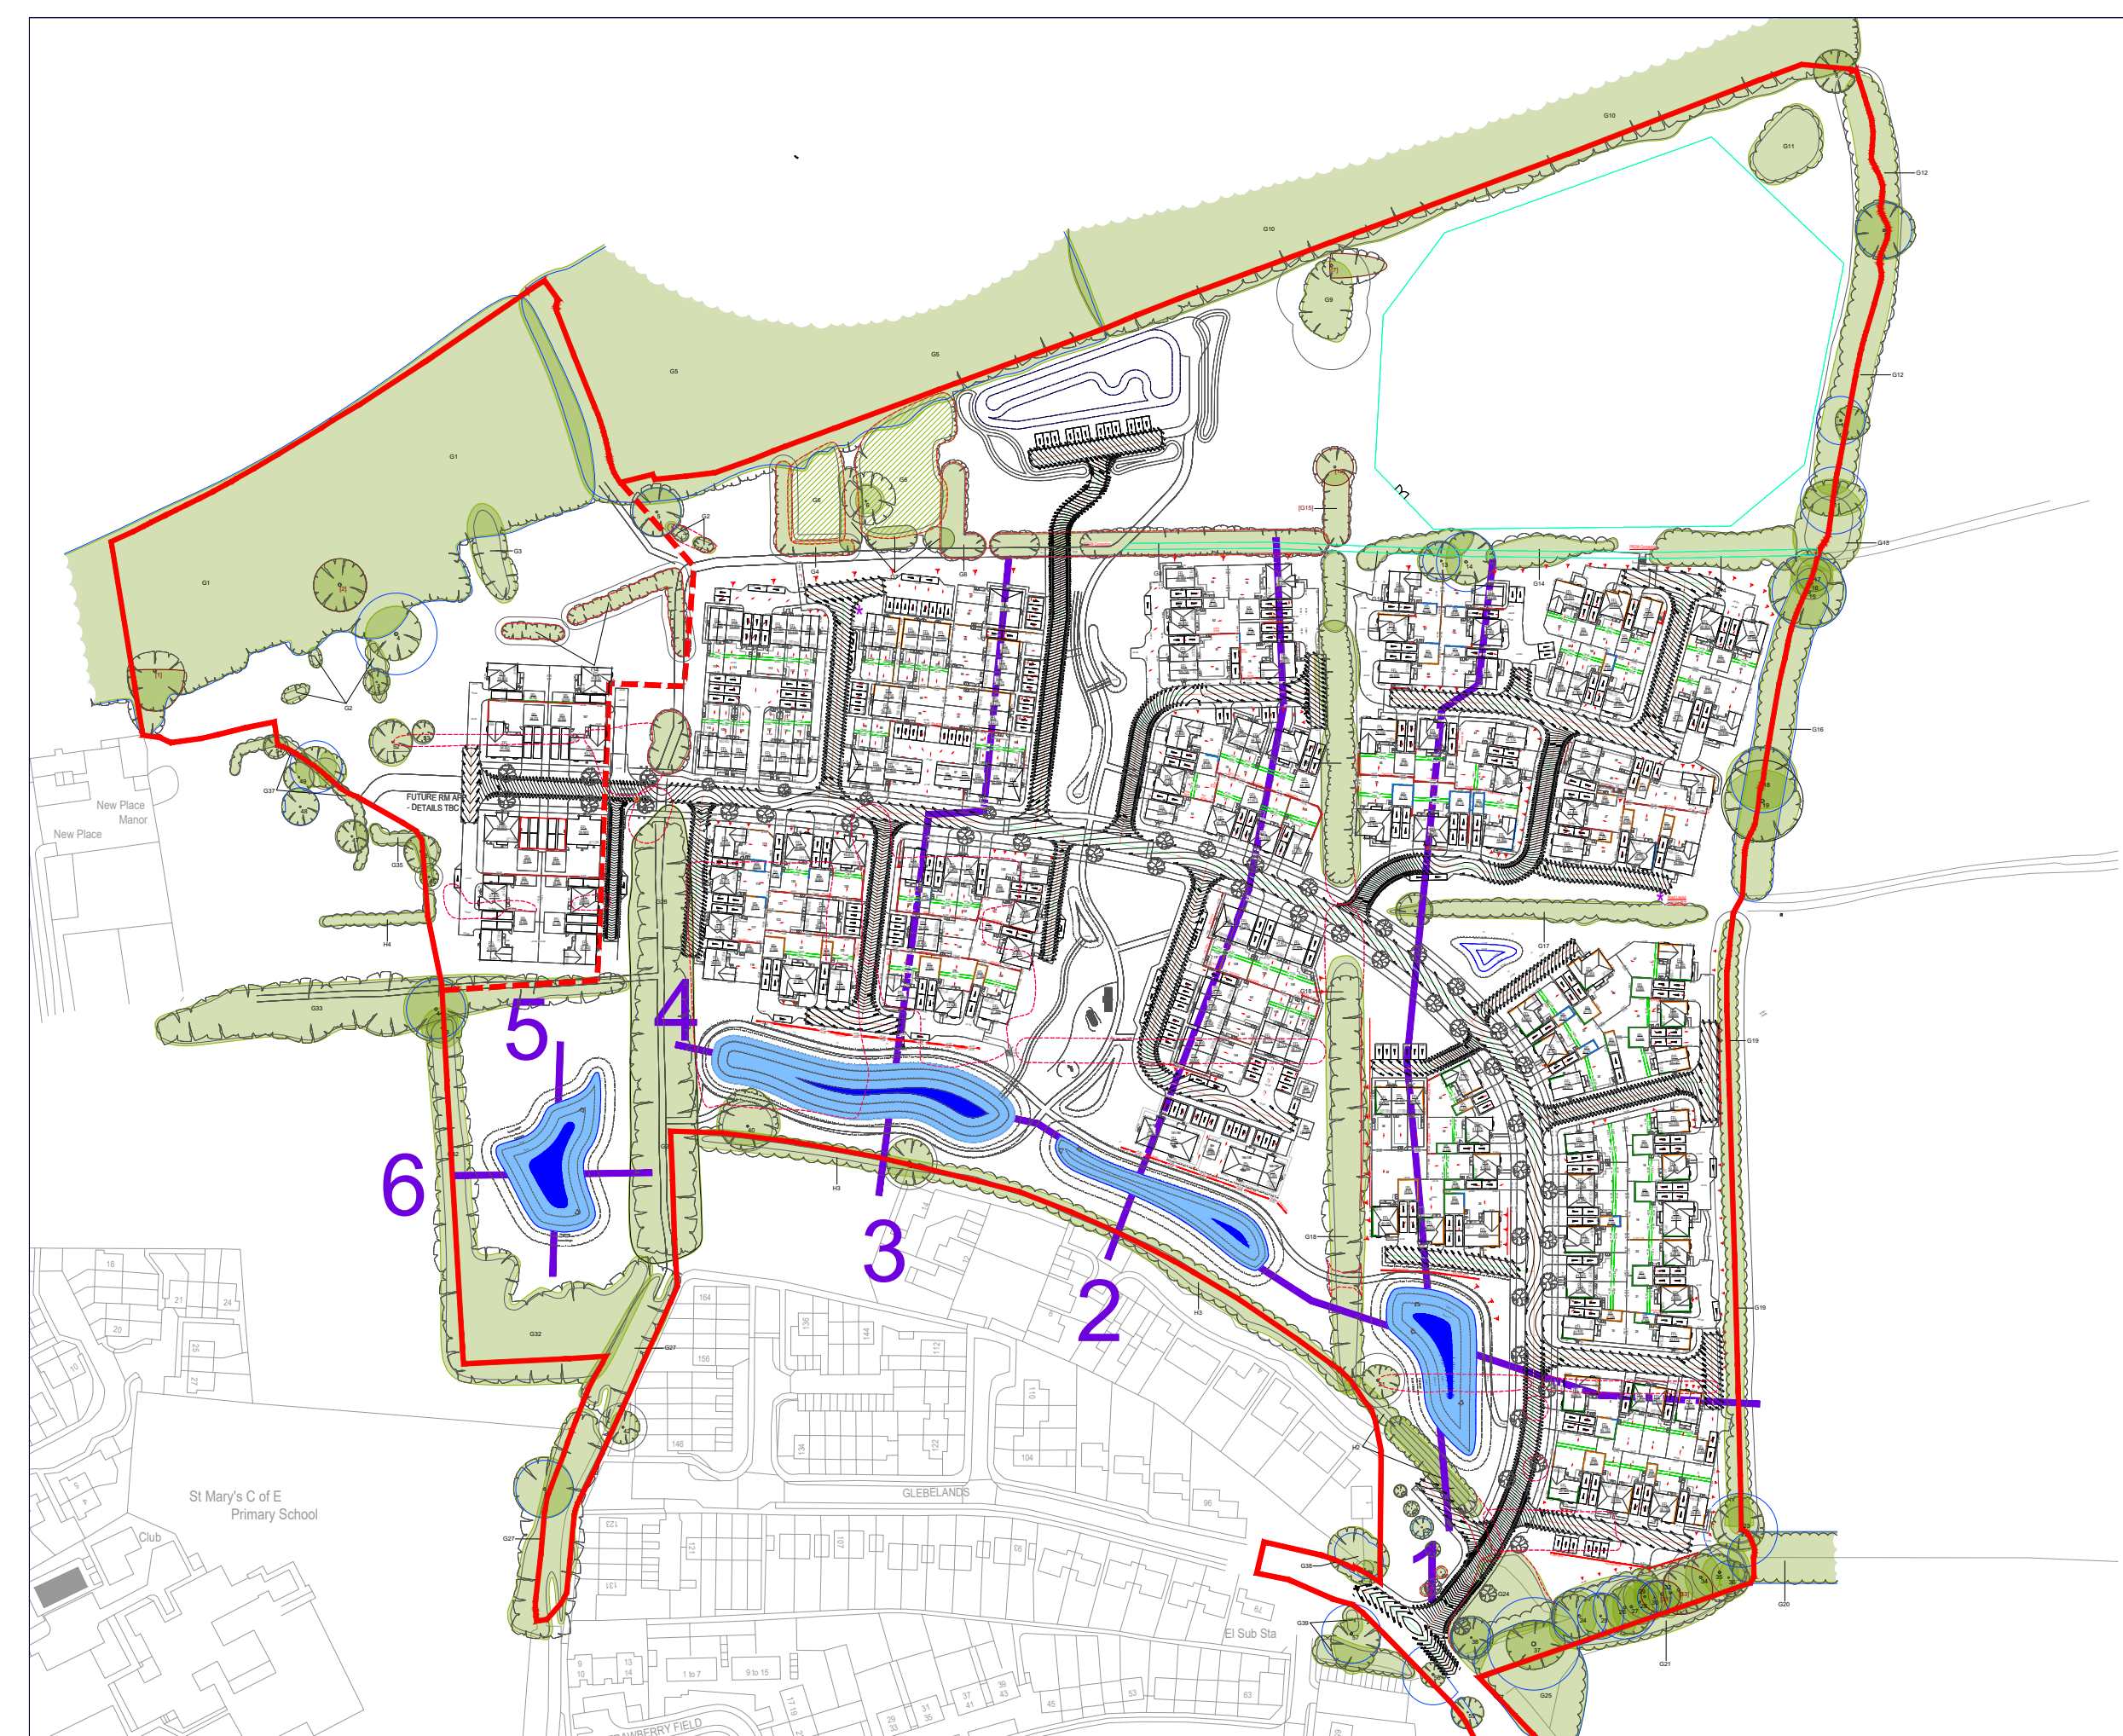
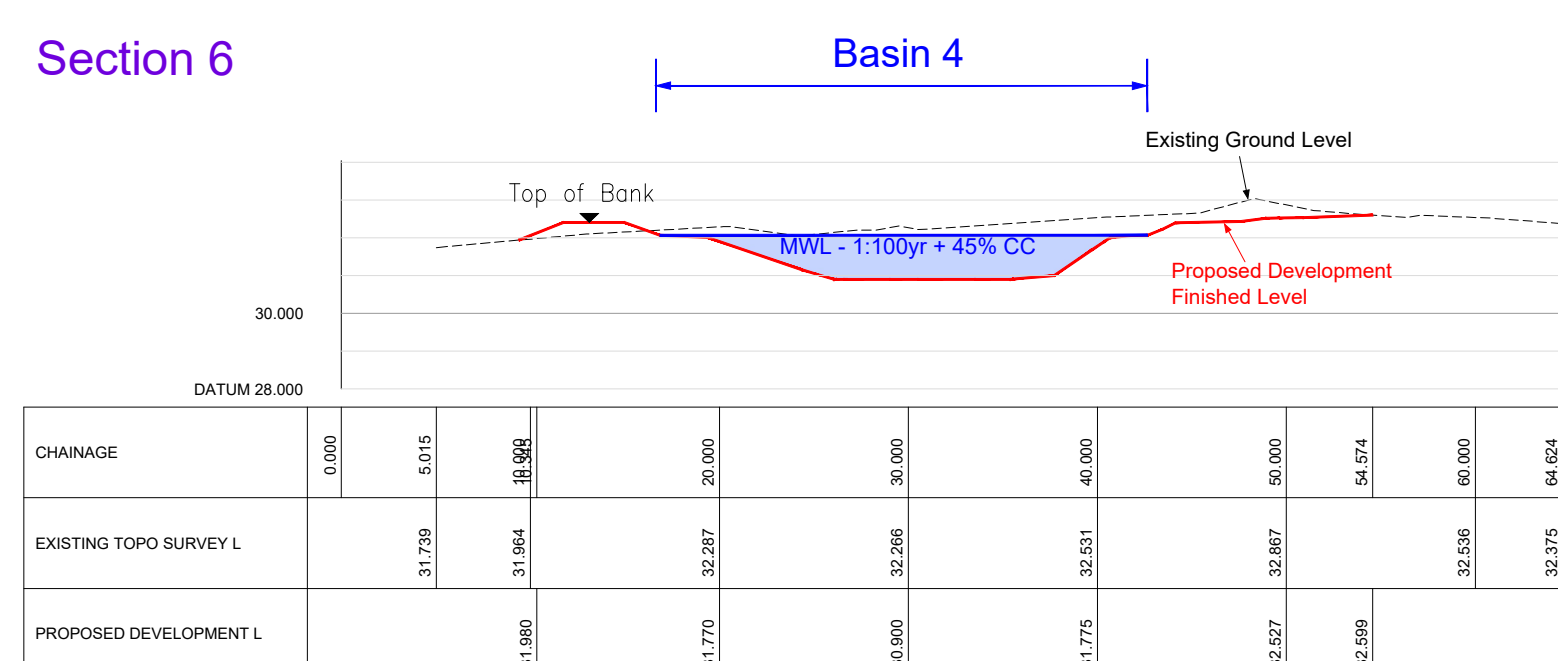
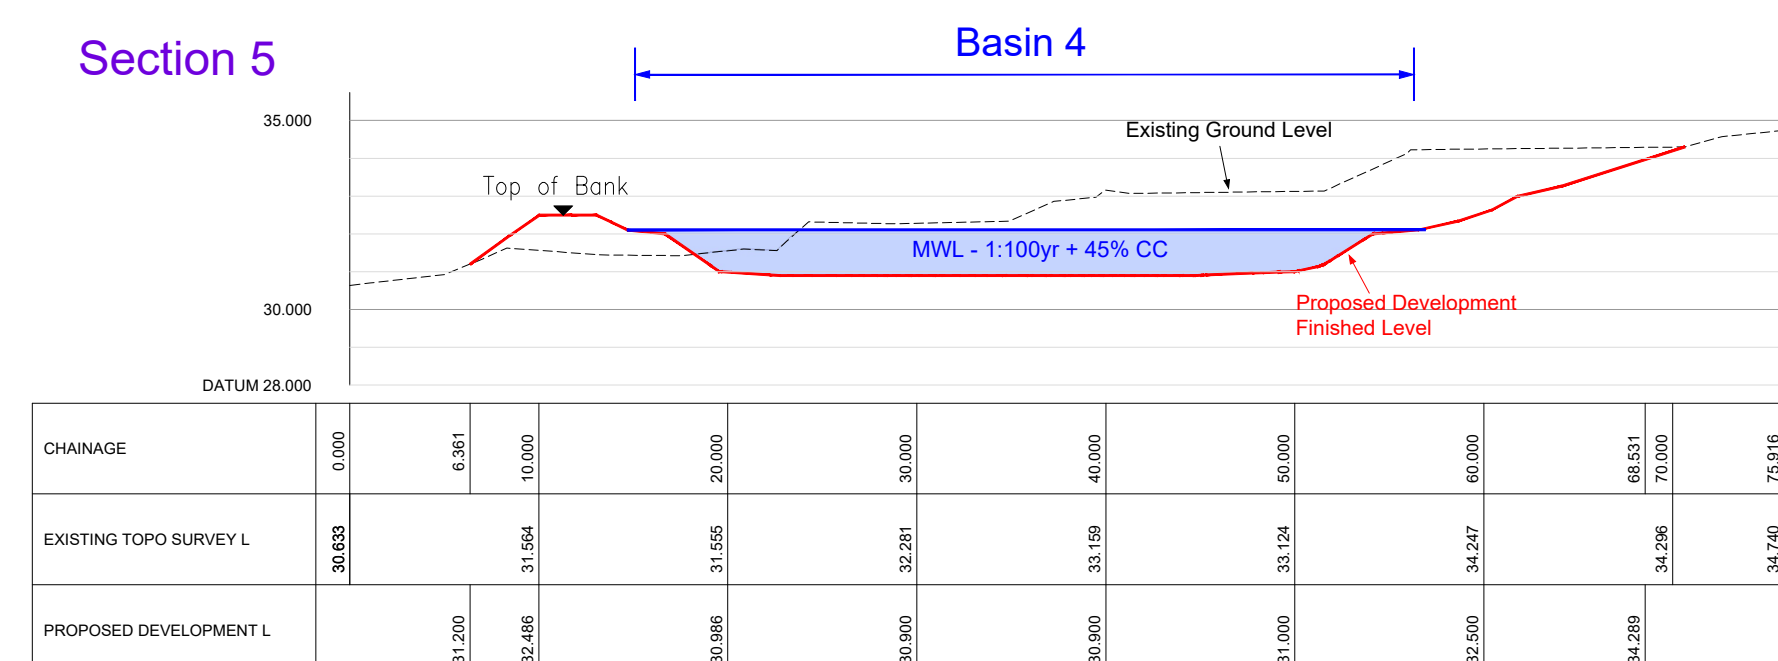
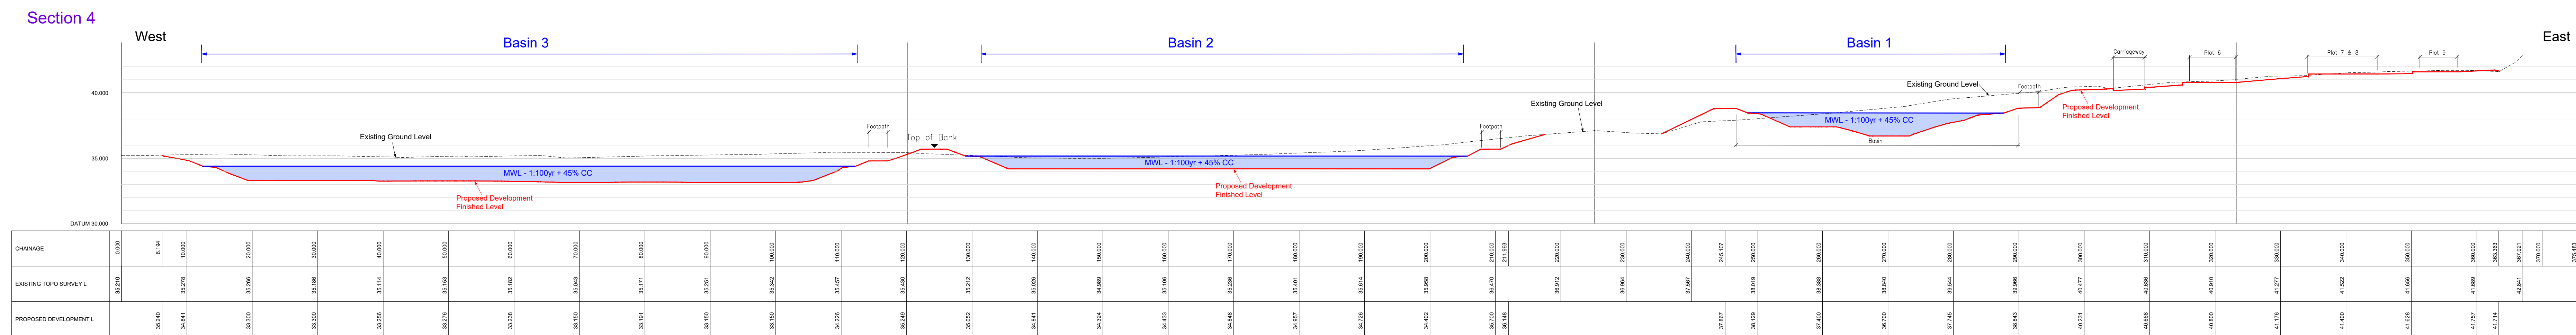
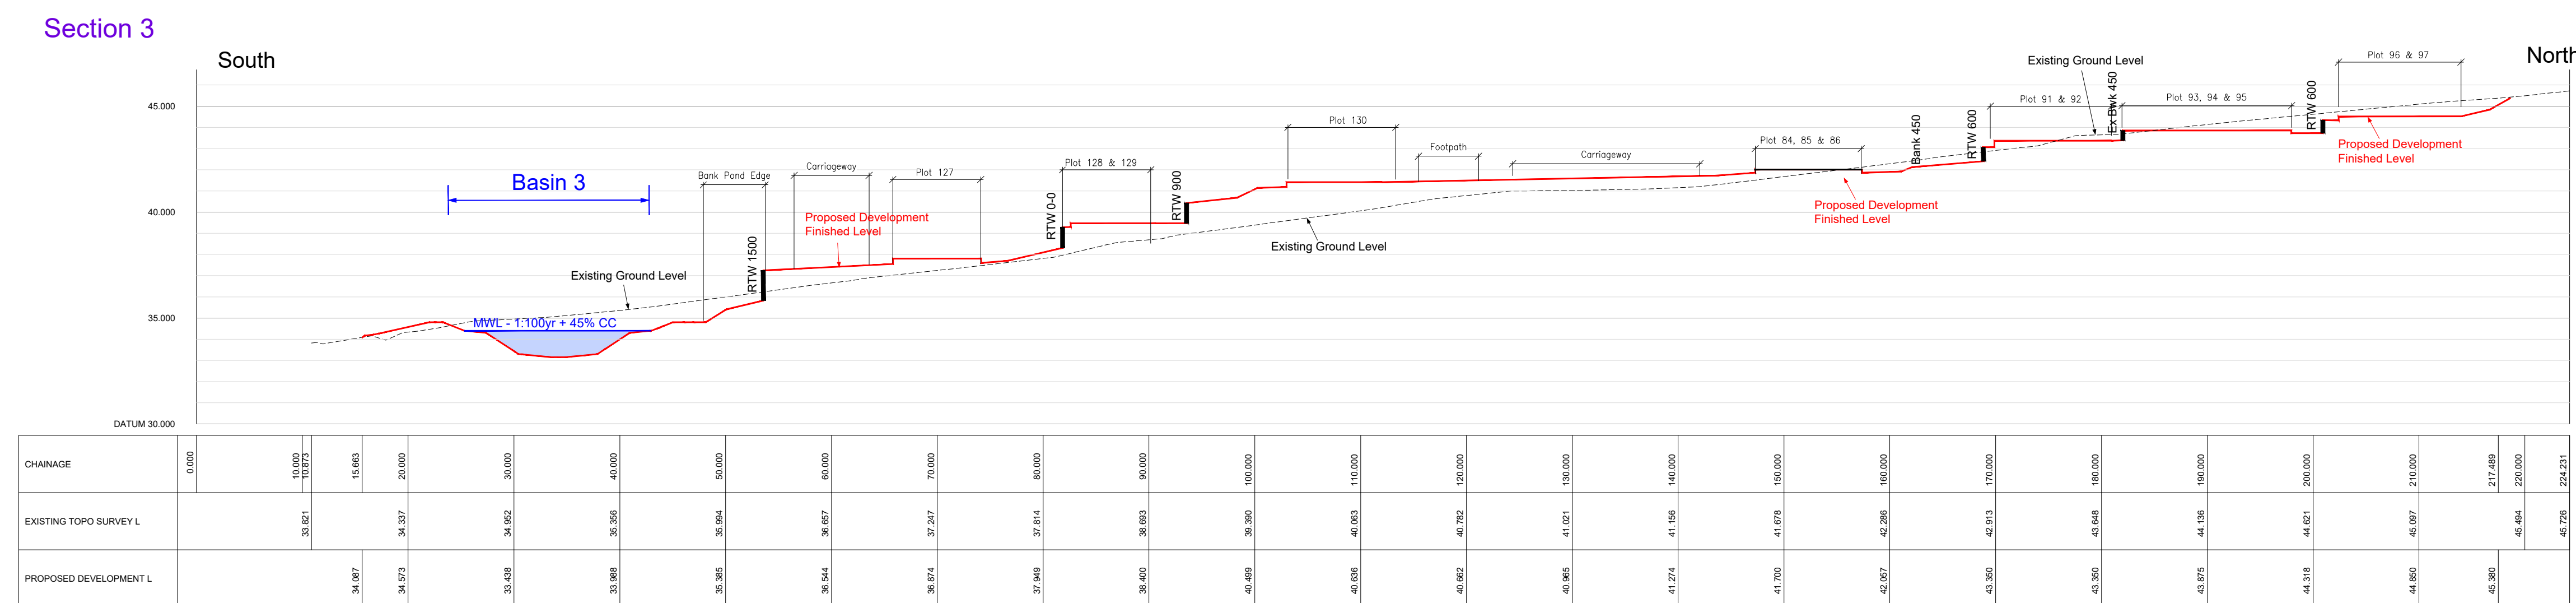


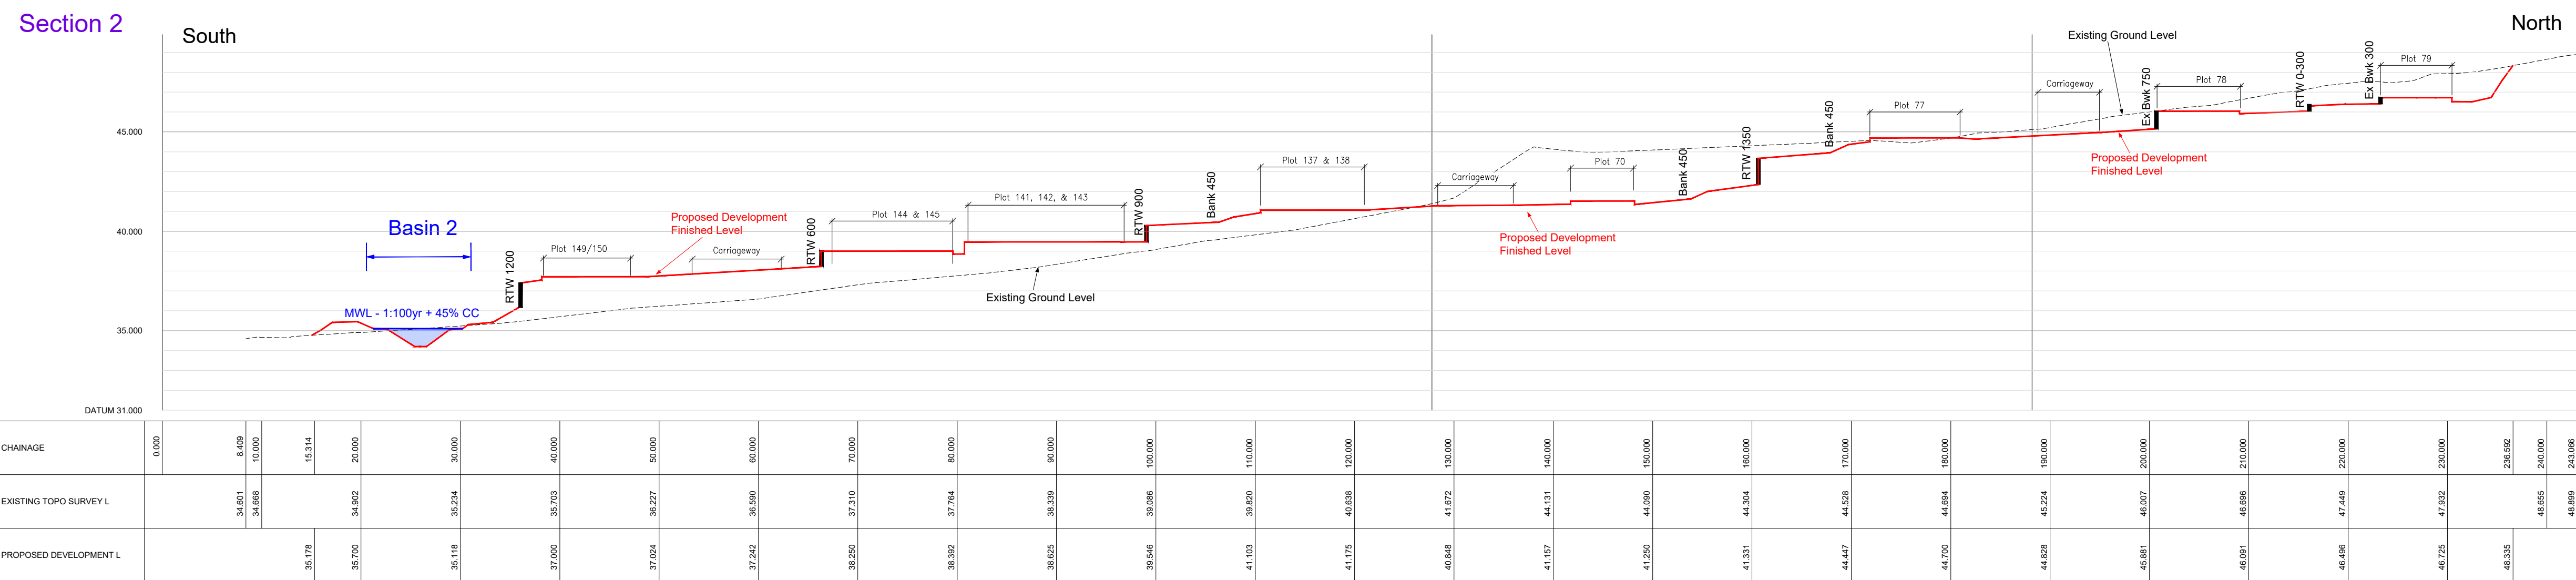

Abnormal or unusual residual risks associated with the design outcomes shown on this drawing are:-

RSK LDE LTD has followed its Design Risk Management process to Hazard Elimination and Risk reduction in developing the designs on this drawing.

Abnormal or unusual residual risks may be shown above where it is considered that such risk may not normally be expected by competent persons engaged on work of this nature or type.

Notes

1. This drawing is to be read in conjunction with all relevant Architects and Engineers drawings and specifications.
2. Layout based on the Finc Architects Layout dated 2024.10.24.
3. Topo Survey information taken from NUC Surveys Drawing S1572, dated March 2019.
4. All levels quoted are in metres A.O.D.
5. For Longitudinal Sections see Drawing No's 8013-8022
6. For Drainage Layout see Drawing No's 8301-8302.
7. For Levels Layout see Drawing 8201-8202
8. All plot accesses are to be either level, stepped or ramped in accordance with The Regulations 2010 Part M and are indicated on this drawing.
9. All roads to be to West Sussex adoptable standards, although the road network will offer for adoption.

P02	13.12.2024	Issued for PLANNING RESUBMISSION	SH	GXA
P01	25.10.24	For Planning.	SH	GXA
Rev.	Date	Amendment	Drawn	Chkd.



Abbey Park Tel: +44 (0) 24 7650 5900
Humber Road Fax: +44 (0) 24 7650 1417
Coventry Email: info@rsk.co.uk
CV3 4AQ Web: www.rsk.co.uk
United Kingdom

Client **BARRATT DAVID WILSON**
(SOUTHERN COUNTIES)

Project Title

NEW PLACE FARM, PULBOROUGH
WEST SUSSEX

Status	PLANNING
--------	----------

Drawing Title

SITE SECTIONS

Drawn	Date	Checked	Date	Approved	Date
SH	25.10.24	GXA	25.10.24	AM	25.10.

Scale 1:500	Orig Size A0	Dimensions m
----------------	-----------------	-----------------

Project No. 890815	Drawing File 890815-R5X-ZZ-XX-DR-C-8410 Site Sections WASTE
------------------------------	--

Drawing No.							Rev.
890815	RSK	ZZ	XX	DB	C	8210	PC

