


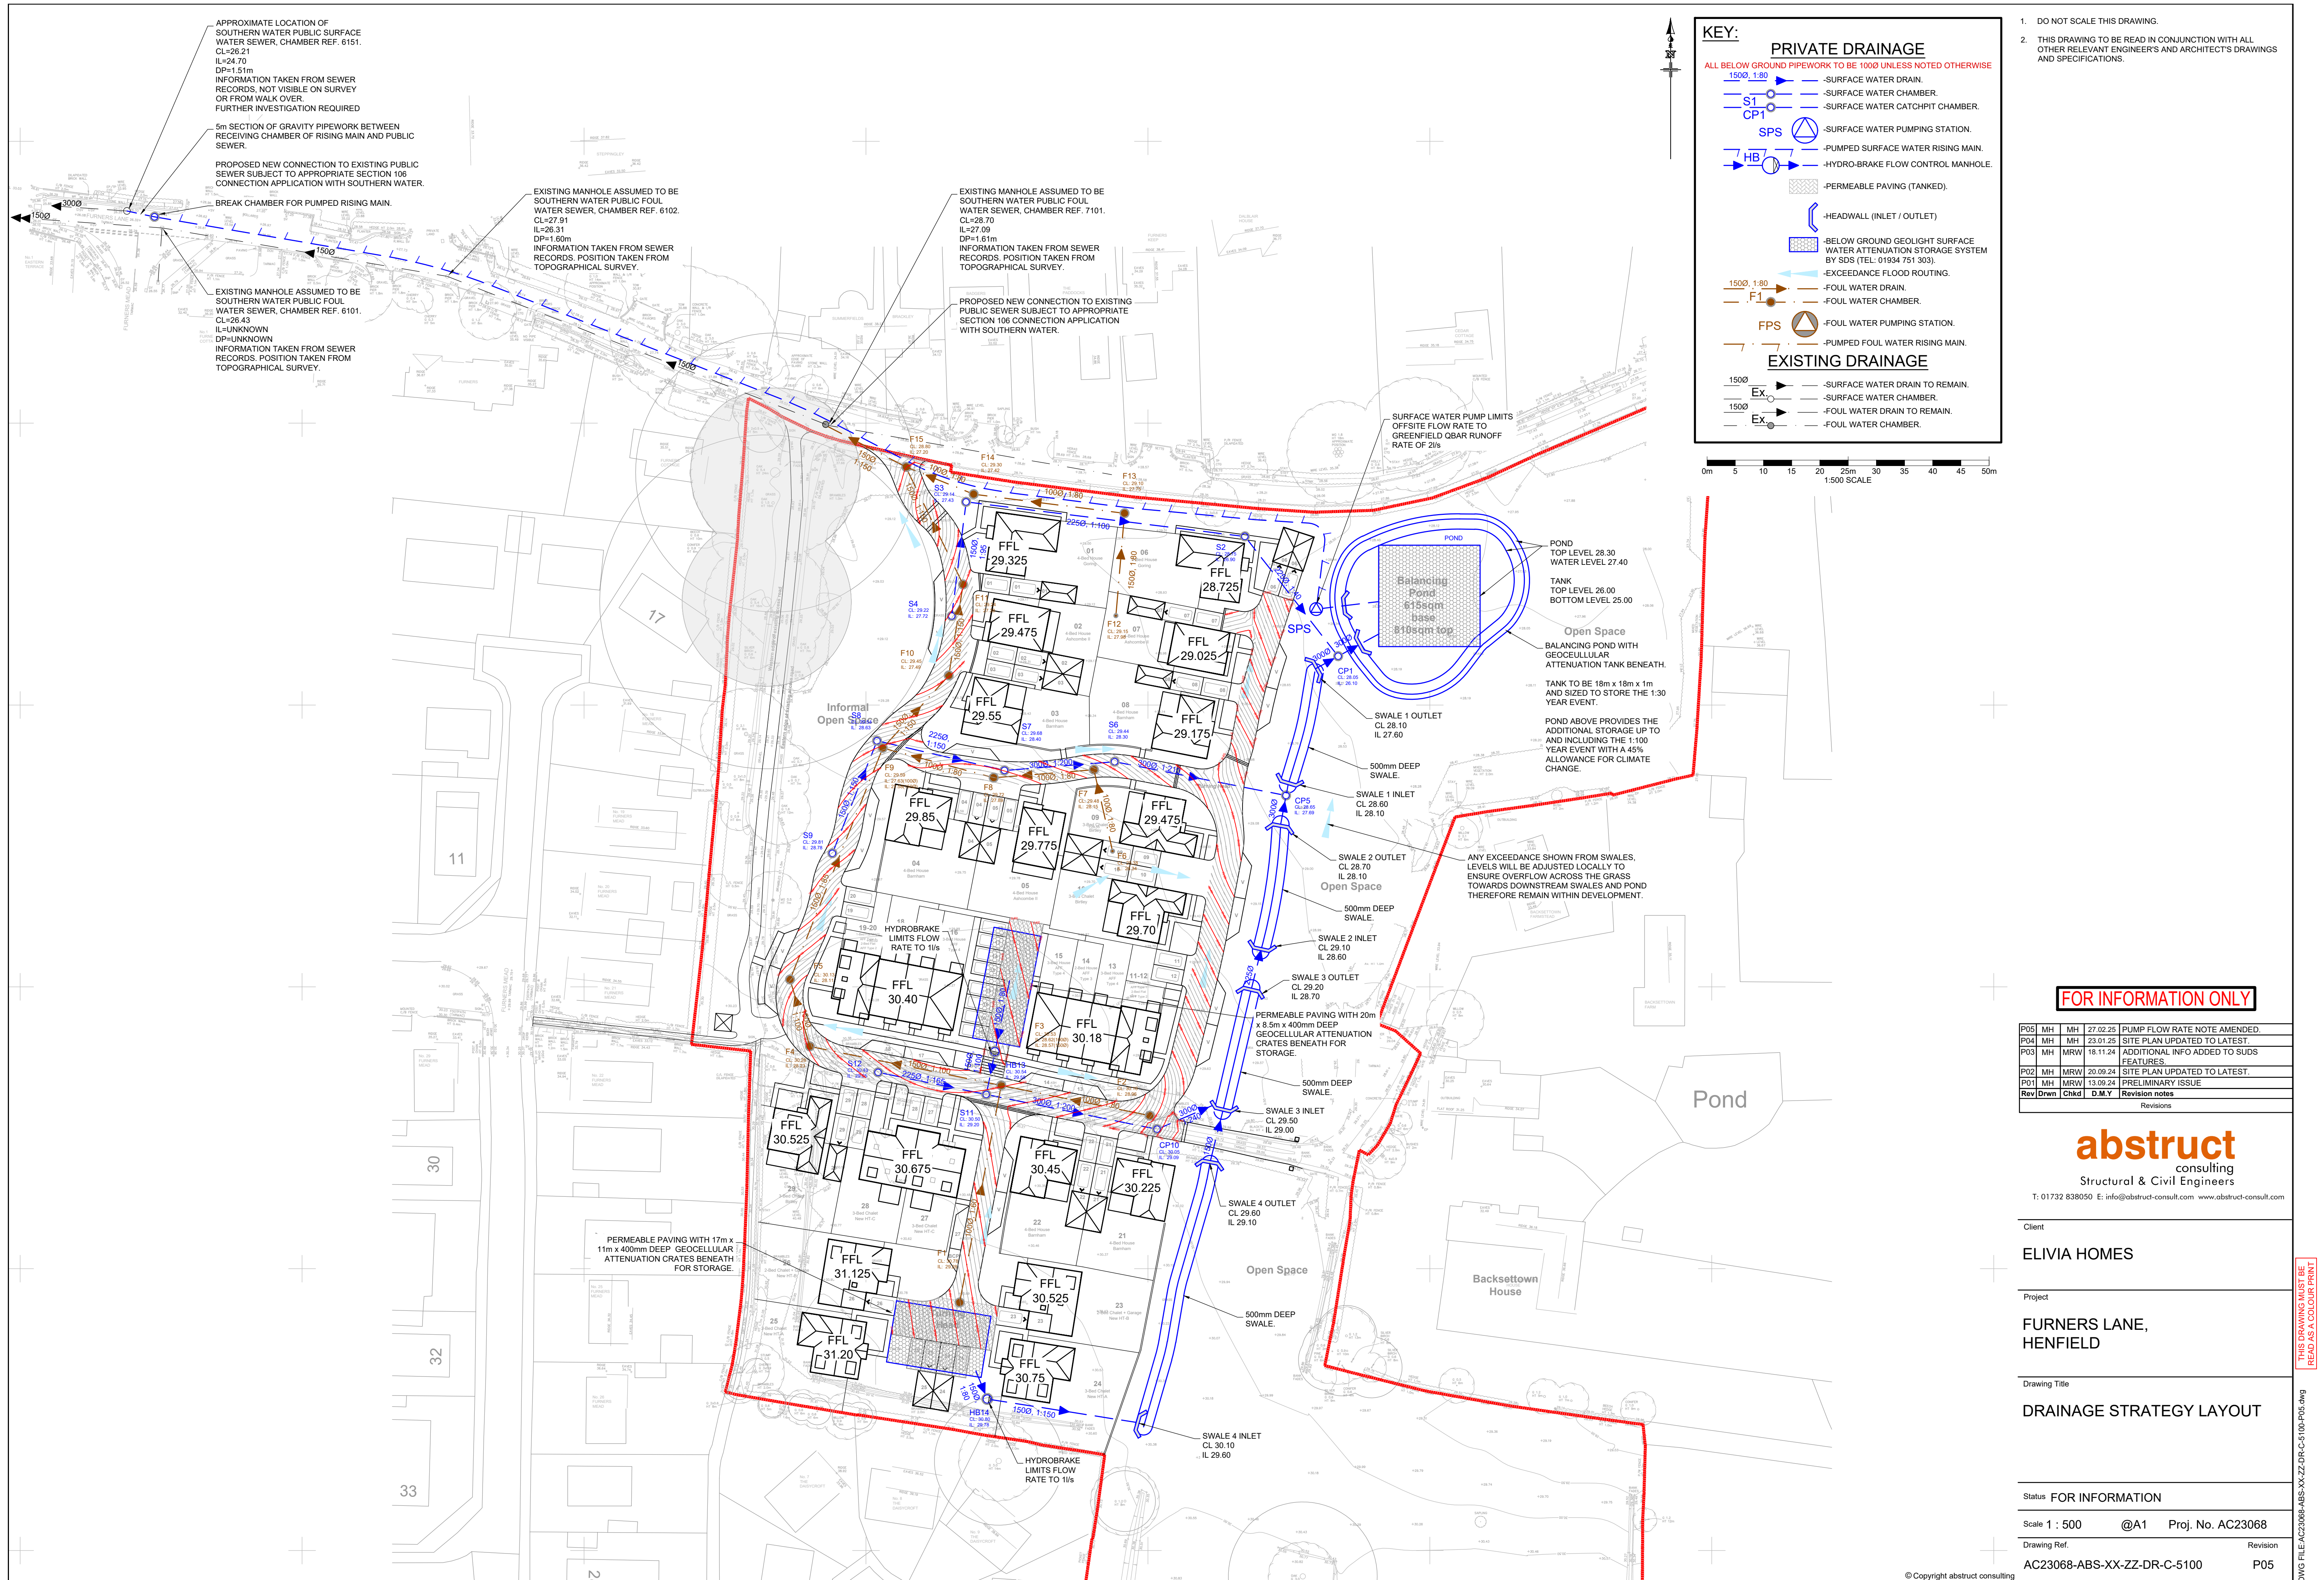

FOR INFORMATION ONLY

|           |      |      |          |                                         |
|-----------|------|------|----------|-----------------------------------------|
| P05       | MH   | MH   | 27.02.25 | PUMP FLOW RATE NOTE AMENDED.            |
| P04       | MH   | MH   | 23.01.25 | SITE PLAN UPDATED TO LATEST.            |
| P03       | MH   | MRW  | 18.11.24 | ADDITIONAL INFO ADDED TO SUDS FEATURES. |
| P02       | MH   | MRW  | 20.09.24 | SITE PLAN UPDATED TO LATEST.            |
| P01       | MH   | MRW  | 13.09.24 | PRELIMINARY ISSUE                       |
| Rev       | Drwn | Chkd | D.M.Y    | Revision notes                          |
| Revisions |      |      |          |                                         |

abstruct  
consulting

Structural & Civil Engineers

T: 01732 838050 E: info@abstruct-consult.com www.abstruct-consult.com

Client

ELIVIA HOMES

Project

FURNERS LANE,  
HENFIELD

Drawing Title

DRAINAGE STRATEGY LAYOUT

Status FOR INFORMATION

Scale 1 : 500 @A1 Proj. No. AC23068

Drawing Ref. AC23068-ABS-XX-ZZ-DR-C-5100

Revision P05